

LIGHTING PLAN  
1/4"=1'-0"

KEY NOTES

1. WIRE CIRCUIT THRU EXISTING TIME CLOCK "TC-4" FOR LIGHTING CONTROL . SEE DETAIL ON THIS SHEET.
2. RELOCATED OVERRIDE SWITCH FOR OVERRIDE CONTROL OF TIMECLOCK CIRCUIT FOR OPEN AREA LIGHTING IN SPACE.
3. CIRCUIT TO EXISTING LIGHTING CIRCUIT IN AREA. NO NEW LOAD ADDED.
4. NEW FIXTURES TO MATCH EXISTING. COORDINATE IN FIELD.

GENERAL NOTE

1. CONNECT ALL EXIT SIGNS AND EMERGENCY BATTERY PACKS IN LIGHT FIXTURES AHEAD OF LIGHTING CONTROL DEVICE.

ISSUED FOR PERMIT	
KAMM CONSULTING PROJECT #: 2013-0919 PROJECT MANAGER: DUANE MILLAR	
<b>KAMM Consulting</b> 1408 Orange Avenue Fort Pierce, Florida 34950 Phone 772.595.1744 Fax 772.595.1745 engineering@kammconsulting.com Certification of Authorization #8189	
PRINCIPAL Bradly L. Brown Florida License #58232	date signed

Sheet title: LIGHTING PLAN

file name:

project no:

date:

drawn by:

checked by:

revisions:


Tenant Improvements for:

NOVATIONS

@ECOPLEX

1641 Worthington Road  
West Palm Beach, Florida

COPYRIGHT 2010  
THESE DRAWINGS ARE FOR THE  
EXCLUSIVE USE OF GLIDDEN SPINA  
& PARTNERS, INC. AND MAY NOT BE  
REPRODUCED, REPRODUCED OR USED  
IN ANY MANNER WITHOUT THE  
EXPRESS WRITTEN CONSENT OF  
GLIDDEN SPINA & PARTNERS, INC.  
ALL RIGHTS RESERVED

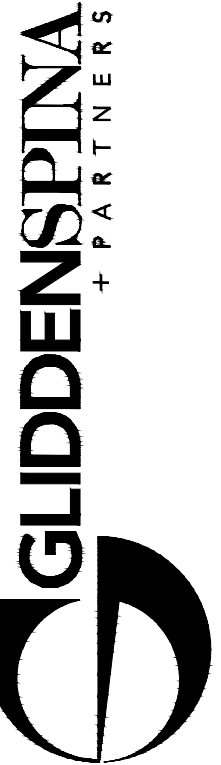

Architecture • Interior Design  
John Glidden #86539 • Keith M. Spina # AFI3419

1401 FORUM WAY, SUITE #100  
WEST PALM BEACH, FLORIDA 33401  
561.684.6844 • Fax 561.684.5594  
gliddenspina.com  
FL Lic. # AA26002399

E2.1