

KEY NOTES

1 CONTRACTOR SHALL FIELD VERIFY PRIOR TO INSTALLATION FIELD CONDITIONS ON LOCATION OF FIRE DAMPERS AND SOUND BOOTS. IF DISCREPANCY OCCURS CONTACT ARCHITECT AND ENGINEER PRIOR TO ANY WORK OR PURCHASE OF ITEMS. SEE DETAIL 10 ON M5.1. (TYPICAL)

MECHANICAL PLAN
OVERHEAD RETURN AIR PLAN

1/4"=1'-0"


ISSUED FOR PERMIT	
KAMM CONSULTING PROJECT #: 2013-0919	
PROJECT MANAGER: DUANE MILLAR	
KAMM Consulting 1408 Orange Avenue Fort Pierce, Florida 34950 Phone 772.595.1744 Fax 772.595.1745 engineering@kammconsulting.com Certification of Authorization #8189	
PRINCIPAL Bradly L. Brown	Florida License #58232
date	signed

Sheet title: MECHANICAL PLAN	revisions:
file name:	project no:
date:	drawn by:
checked by:	

M2.1

Tenant Improvements for:
NOVATIONS
@ECOPLEX
1641 Worthington Road
West Palm Beach, Florida

COPYRIGHT 2010
THESE DRAWINGS ARE FOR THE EXCLUSIVE USE OF GLIDDEN SPINA & PARTNERS, INC. AND MAY NOT BE REPRODUCED, REPRODUCED OR USED IN ANY MANNER WITHOUT THE EXPRESS WRITTEN CONSENT OF GLIDDEN SPINA & PARTNERS, INC. ALL RIGHTS RESERVED.

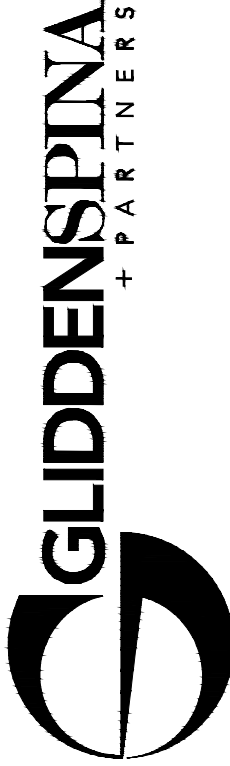

Architecture • Interior Design
John Glidden #86539 • Keith M. Spina # AFI3419

1401 FORUM WAY, SUITE #100
WEST PALM BEACH, FLORIDA 33401
561.684.6844 • Fax 561.684.5594
gliddenspina.com
FL Lic. # AA26002399